


POD
42.1 m²

WIND CLASSIFICATION - /
SOIL CLASSIFICATION - CLASS N/A

TERRAMOD MODULAR

WILLOW

DRAWING REGISTER			
Sheet Number	Sheet Name	Current Revision	Current Revision Date
000	TITLE PAGE	A	22.07.2026
001	WILLOW-2BED	A	22.07.2026
100	VIEW DIRECTORY	A	22.07.2026
110	FLOOR PLAN	A	22.07.2026
111	BATHROOM	A	22.07.2026
112	SECTIONS	A	22.07.2026
113	SECTIONS	A	22.07.2026
114	ELEVATIONS	A	22.07.2026
115	WINDOW/DOOR SCHEDULE	A	22.07.2026
200	CARCASS-BASE FRAME & CAECASS-TOP	A	22.07.2026
201	CARCASS ELEVATIONS	A	22.07.2026
300	STUMPS LAYOUT	A	22.07.2026
400	ELECTRICAL PLAN	A	22.07.2026
401	ELECTRICAL SCHEMATIC + CABLE SCHEDULE	A	22.07.2026
403	HOT/COLD PLUMBING PLAN	A	22.07.2026
500	WATERPROOFIN & GBRACING AREA	A	22.07.2026
501	VINYL FLOORING EXPANSION JOINT	A	22.07.2026
600	WALL SYSTEM-TOP VIVEW	A	22.07.2026
601	FLOOR SYSTEMM & LOW SIDE - GUTTER	A	22.07.2026
TOTAL NUMBER OF SHEET: 19			

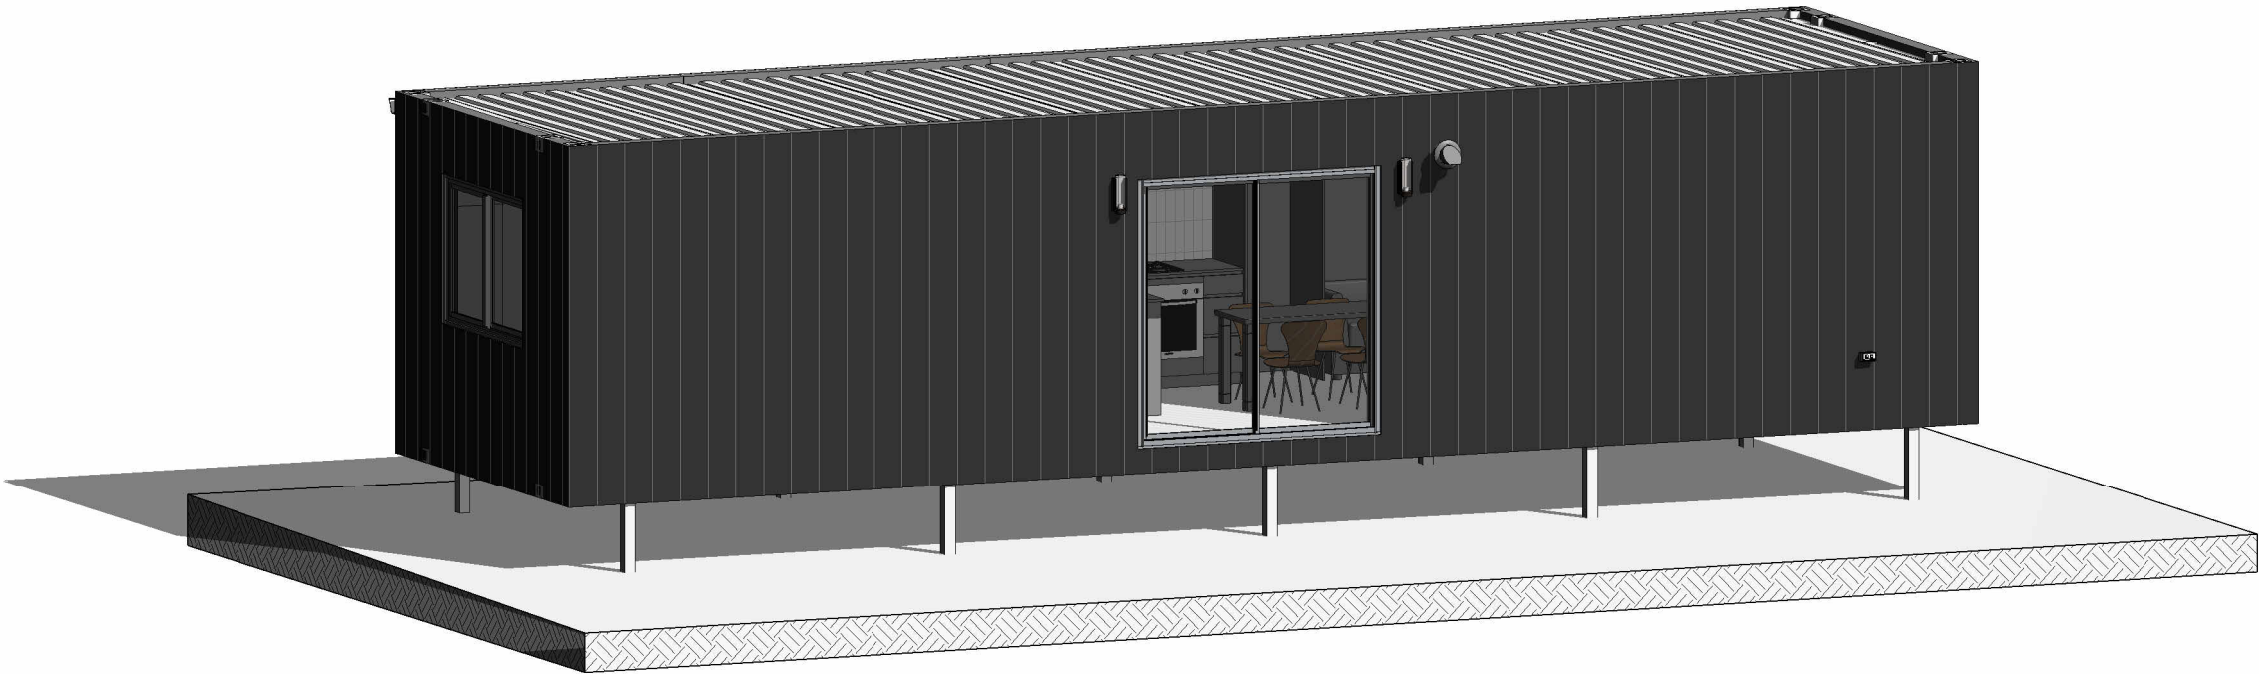

A	Revision 1	22.07.2026
REV	DESCRIPTION	DATE

STYLE: **WILLOW** ADDRESS:
JOB NO.

CLIENT:
SHEET **000** SHEET TOTALS **19**



1 x 40 FT+ POD

WILLOW-2BEDS

42.1 sq/m²


12.19 m x 3.45 m

1: 40 @ A3

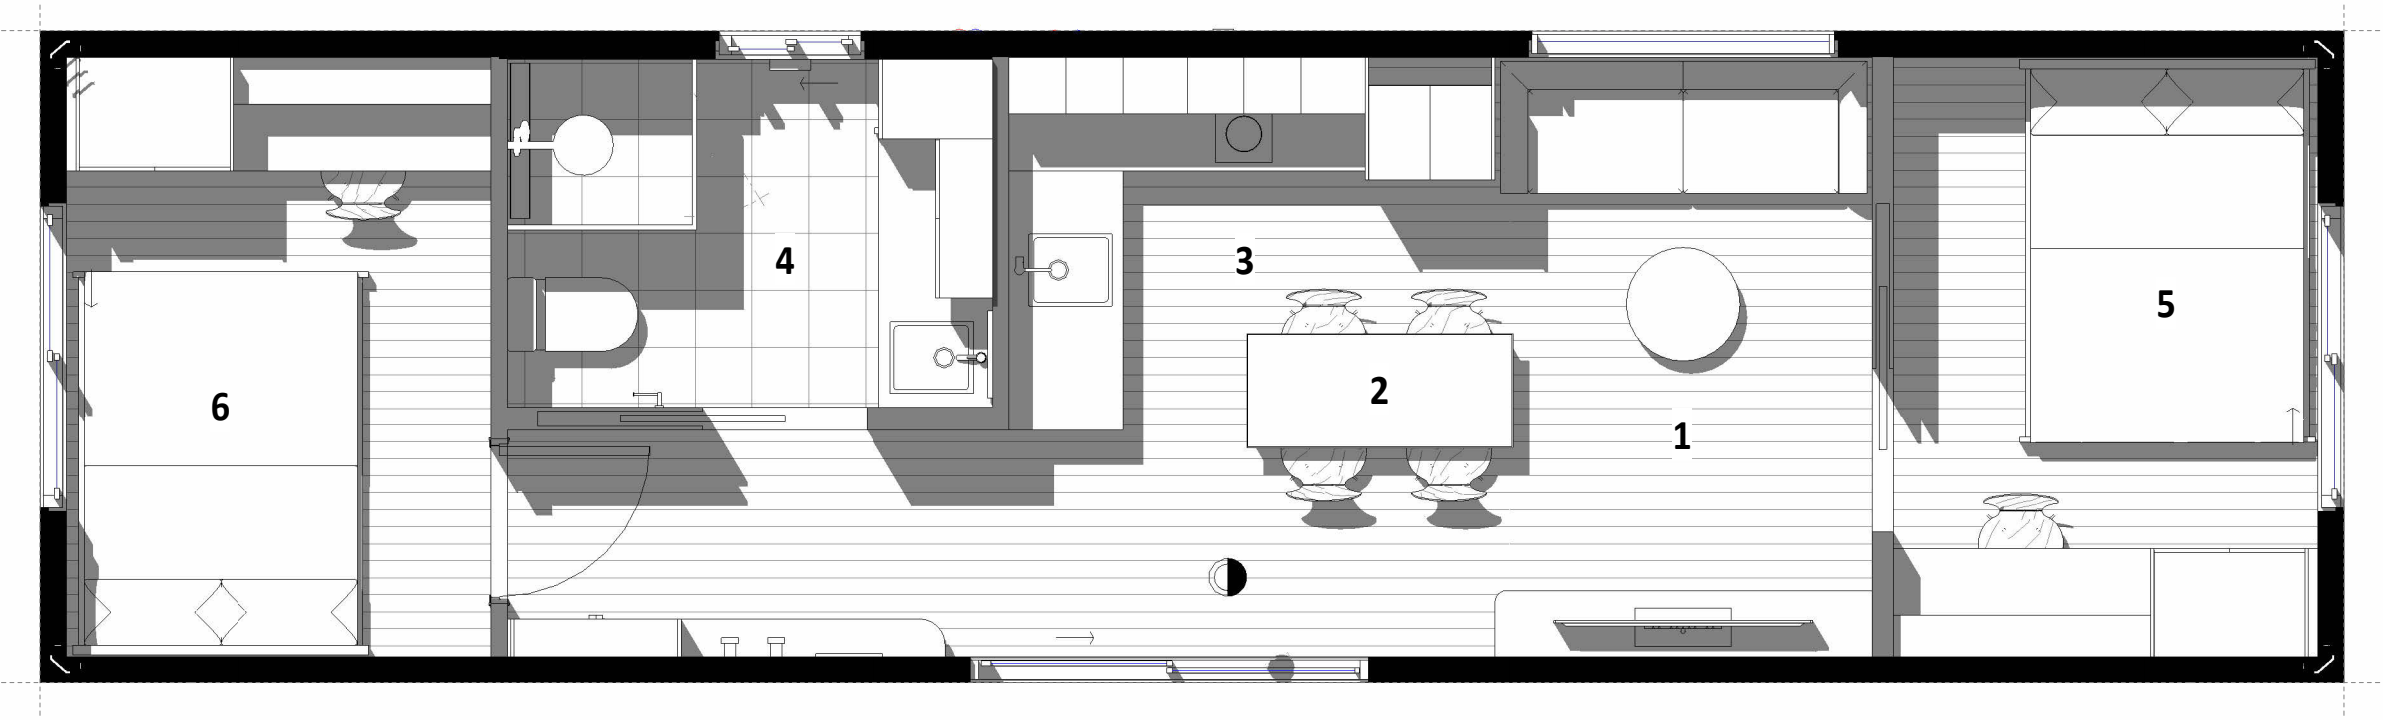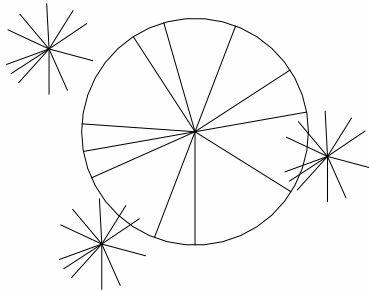


LEGEND

- | | |
|-----------|---------|
| 1.LIVING | 4.BATH |
| 2.DINING | 5.BED 1 |
| 3.KITCHEN | 6.BED 2 |

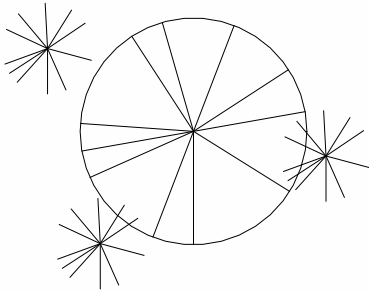

DECK SUPPLIED & INSTALLED BY OTHERS.
IT IS OUTSIDE SCOPE OF WORK, HENCE IT WILL
NOT BE SHOWN AS PART OF THIS DRAWING.

WIND CLASSIFICATION - /
SOIL CLASSIFICATION - CLASS N/A

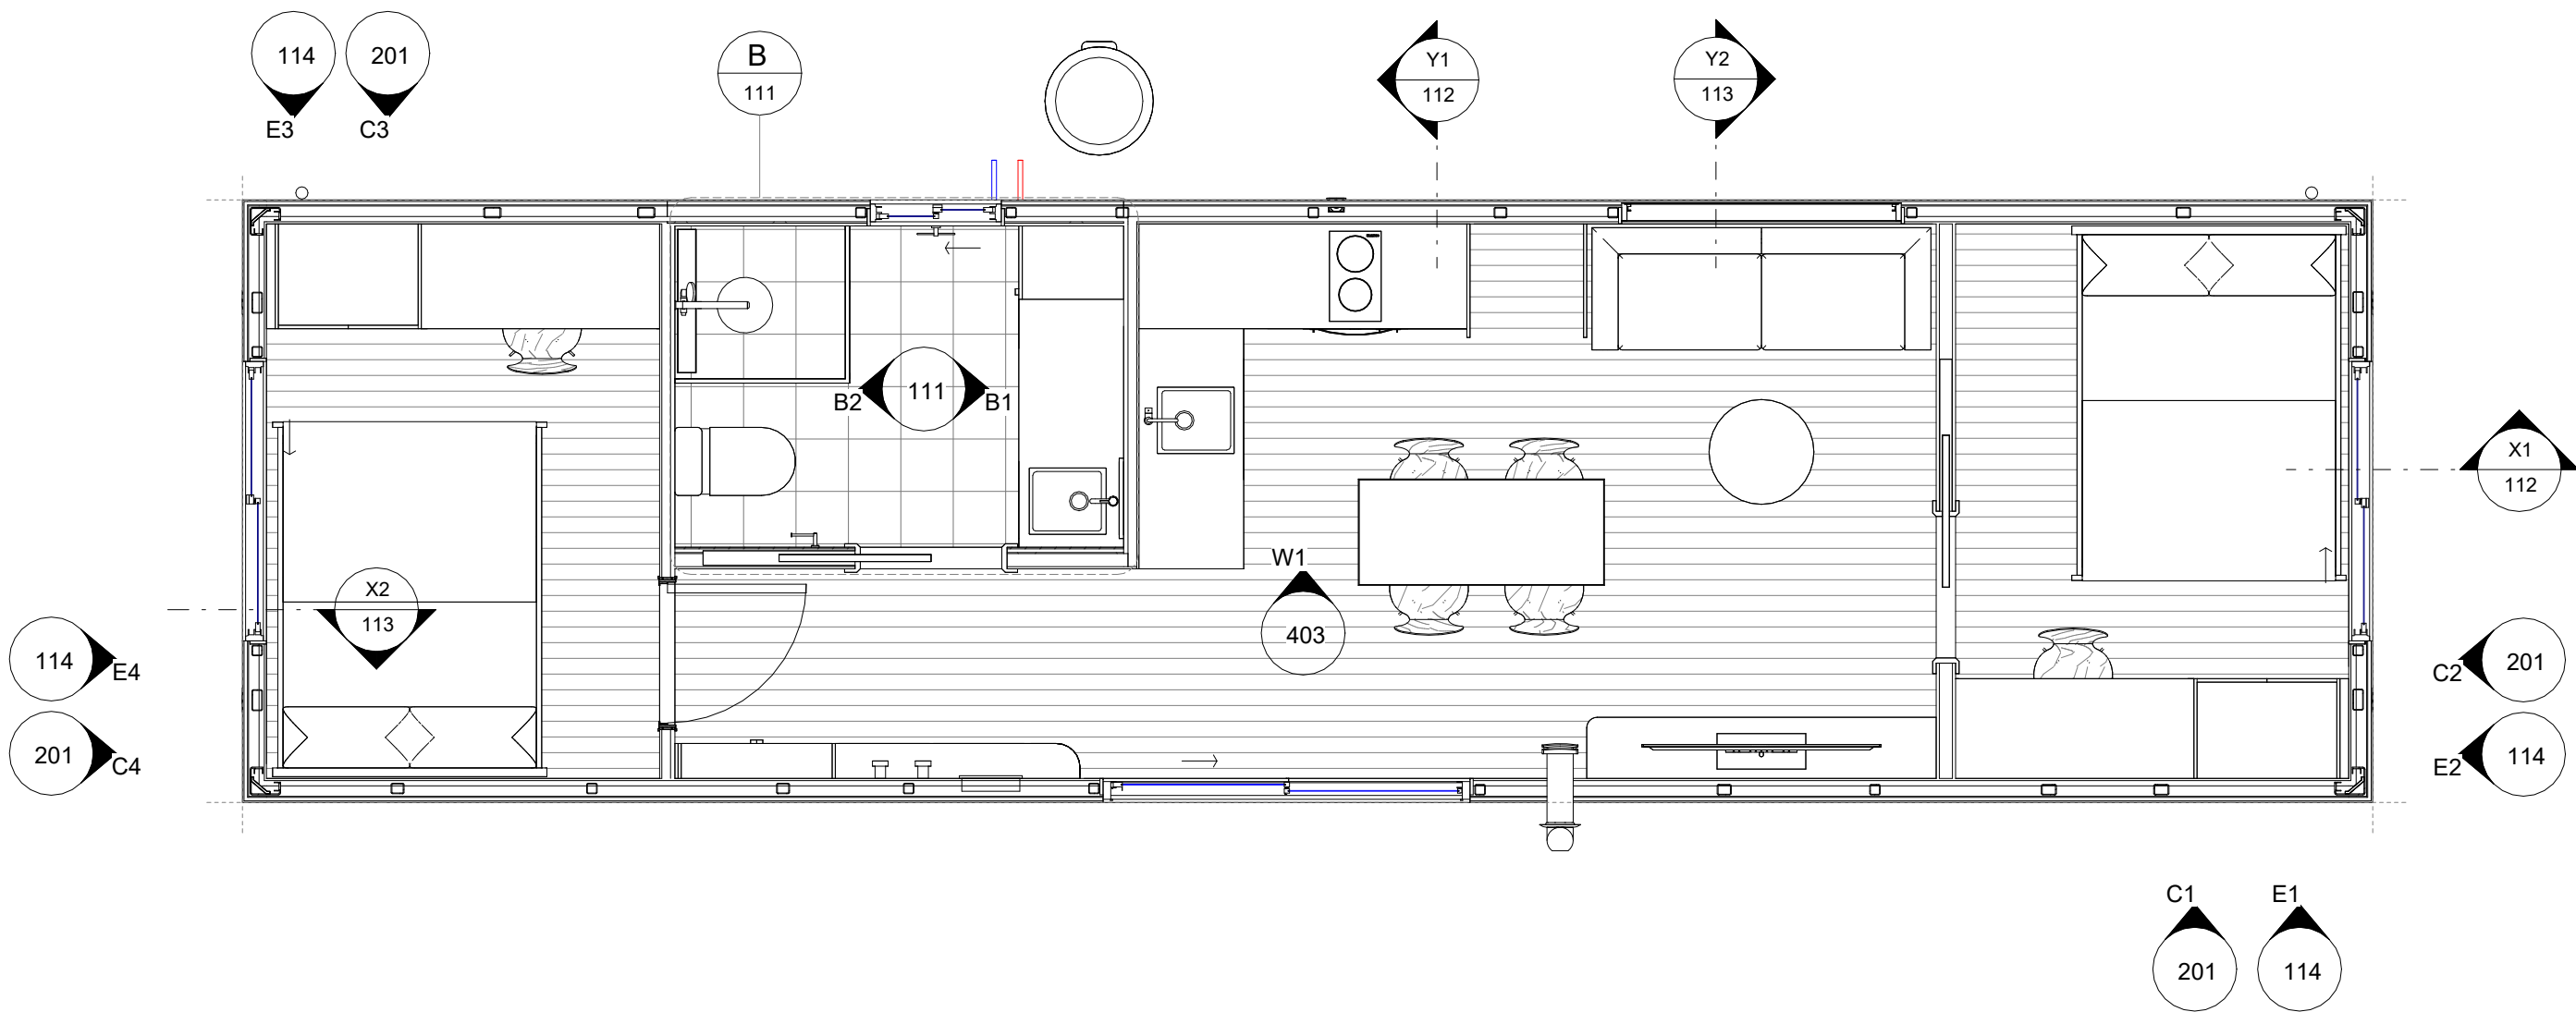

VIEW DIRECTORY
scale 1 : 40


A	Revision 1	22.07.2026
REV	DESCRIPTION	DATE

STYLE: *WILLOW* ADDRESS:
JOB NO.

CLIENT:
SHEET 100 SHEET TOTALS 19

AREA SCHEDULE	
POD	42.1 m ²
Grand total	42.1 m ²

WIND CLASSIFICATION - /
SOIL CLASSIFICATION - CLASS N/A

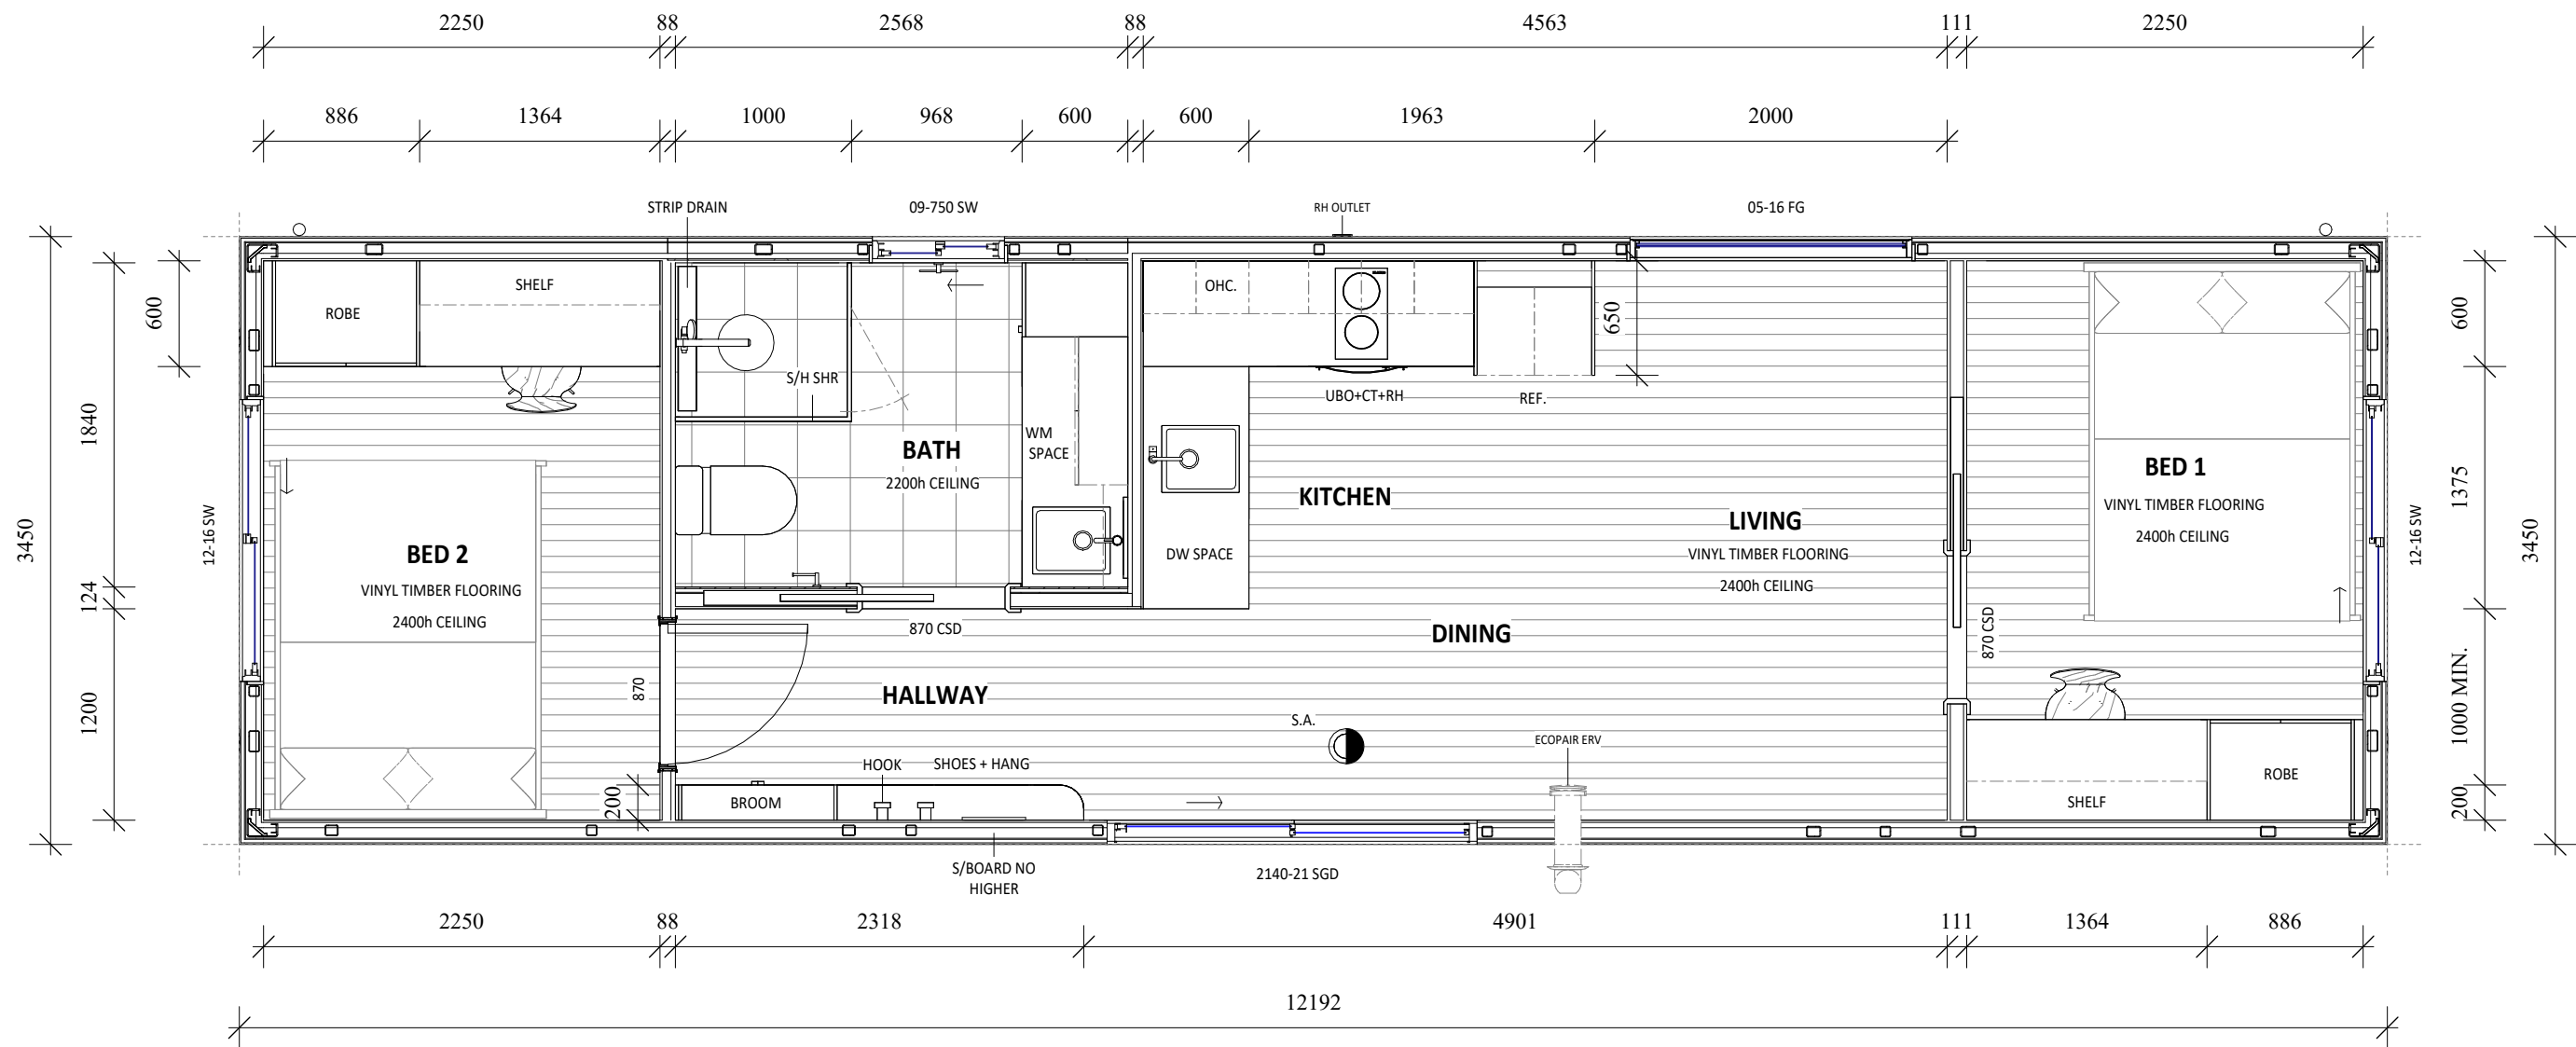

FLOOR PLAN

scale 1:40

NOTES

- ALL EXTERNAL ELEMENTS (PROPOSED DECK & ROOF) DESIGNED & SUPPLIED BY OTHERS.
- DOWNPIPES & GUTTER SUPPLIED INSTALLED ON SITE BY OTHERS.
- SUREFOOT STUMPS FOOTING LAYOUT REFERENCE ONLY, REFER ENGINEERING DRAWINGS.

KEYNOTE LEGEND	
S.G.	SAFETY GLASS TO SHOWER SCREEN.
W.S.A.	WATER STOP ANGLES TO ALL WET AREA DOORWAYS INCLUDING BATHROOMS, WATER CLOSETS AND LAUNDRIES AS PER BCA 2006 PART 3.8.1.8(C)(II).

REV	DESCRIPTION	DATE
A	Revision 1	22.07.2026

STYLE: *WILLOW*


ADDRESS:

JOB NO.

CLIENT:

SHEET 110

SHEET TOTALS 19

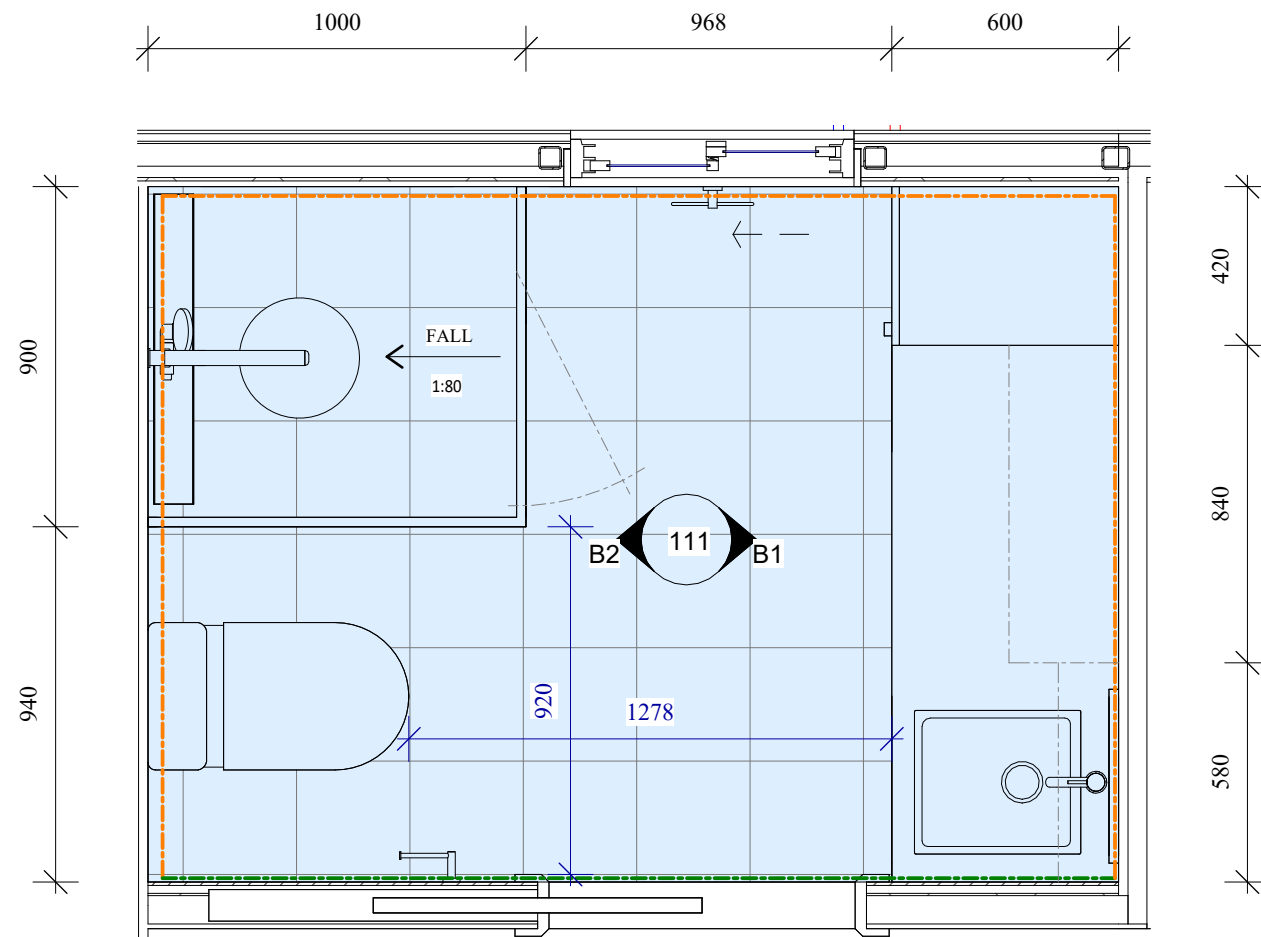


B BATH LAYOUT
100 scale 1:20

- ALL CABINETS SHOP DRAWINGS BY FACTORY TEAM. SITE MEASURE. REQUIRED, DIMENSIONS TO BE ADJUSTED ACCORDINGLY.
- MATERIALS AND FINISHES REFER TO COLOUR SCHEME AND MATERIAL SCHEDULE. TO BE CONFIRMED AT LATER DATE.
- FILLERS HAVE BEEN OMITTED FOR CLARITY. SIZES AND POSITIONS TO BE ROBE DECIDED BY THE FACTORY TEAM.
- ALL DRAWERS HAVE SOFT CLOSE TRACKS.
- DRAWER CARCASS COLOUR TO MATCH DOOR FRONT COLOUR, UNLESS BIN INSIDE CPB NOTED DIFFERENTLY.

CABINETS NOTE



scale 1:50

B2 ELEVATION B2
100 scale 1:25

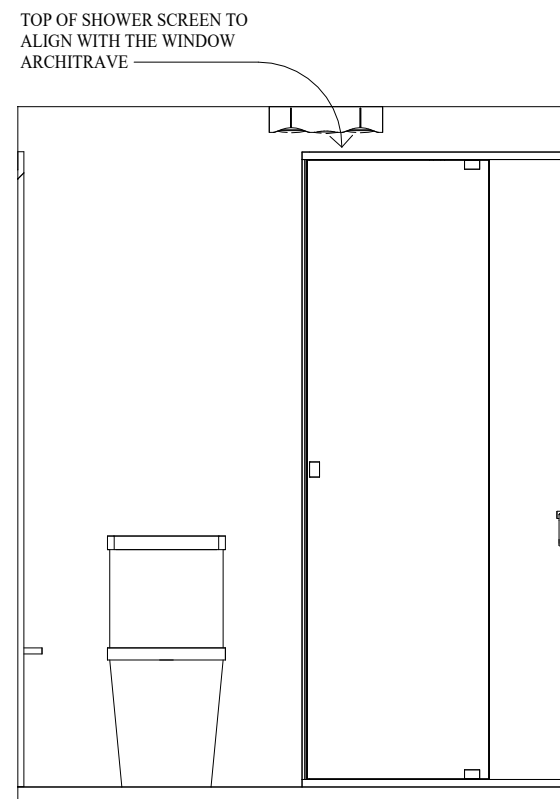

WATERPROOF MEMBRANE


B1 ELEVATION B1
100 scale 1:25

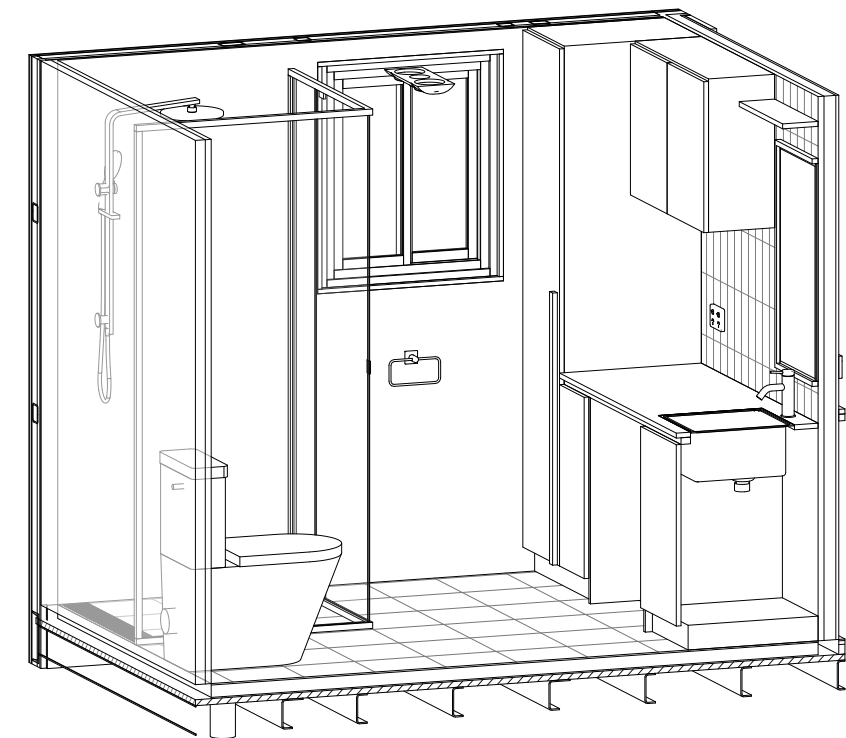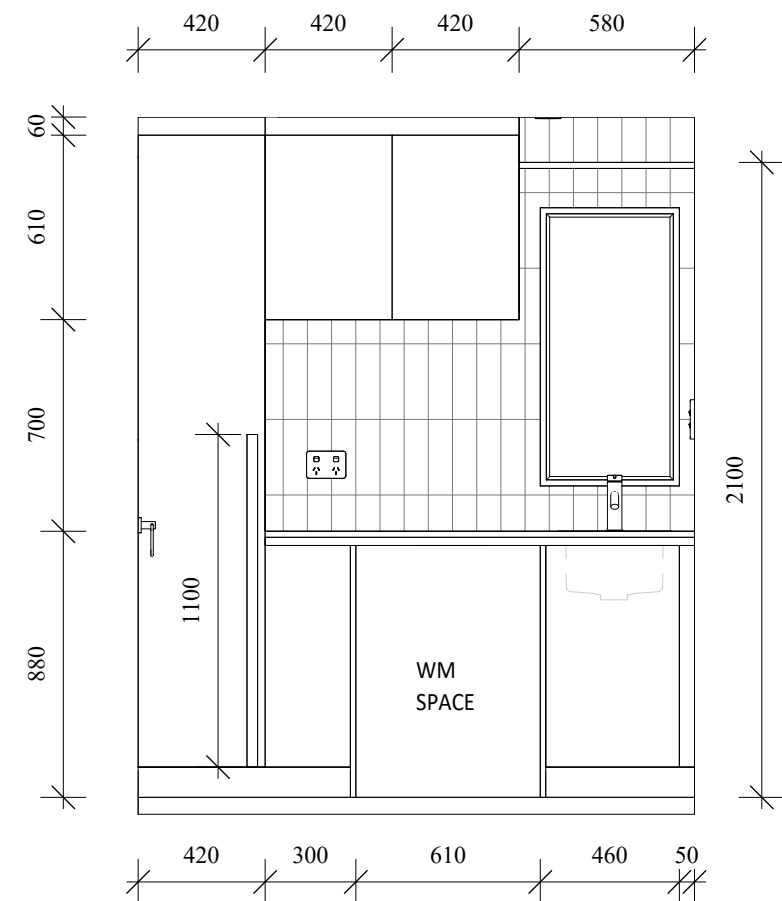


PRODUCTION SET

A	Revision 1	22.07.2026
REV	DESCRIPTION	DATE


WIND CLASSIFICATION - /
SOIL CLASSIFICATION - CLASS N/A

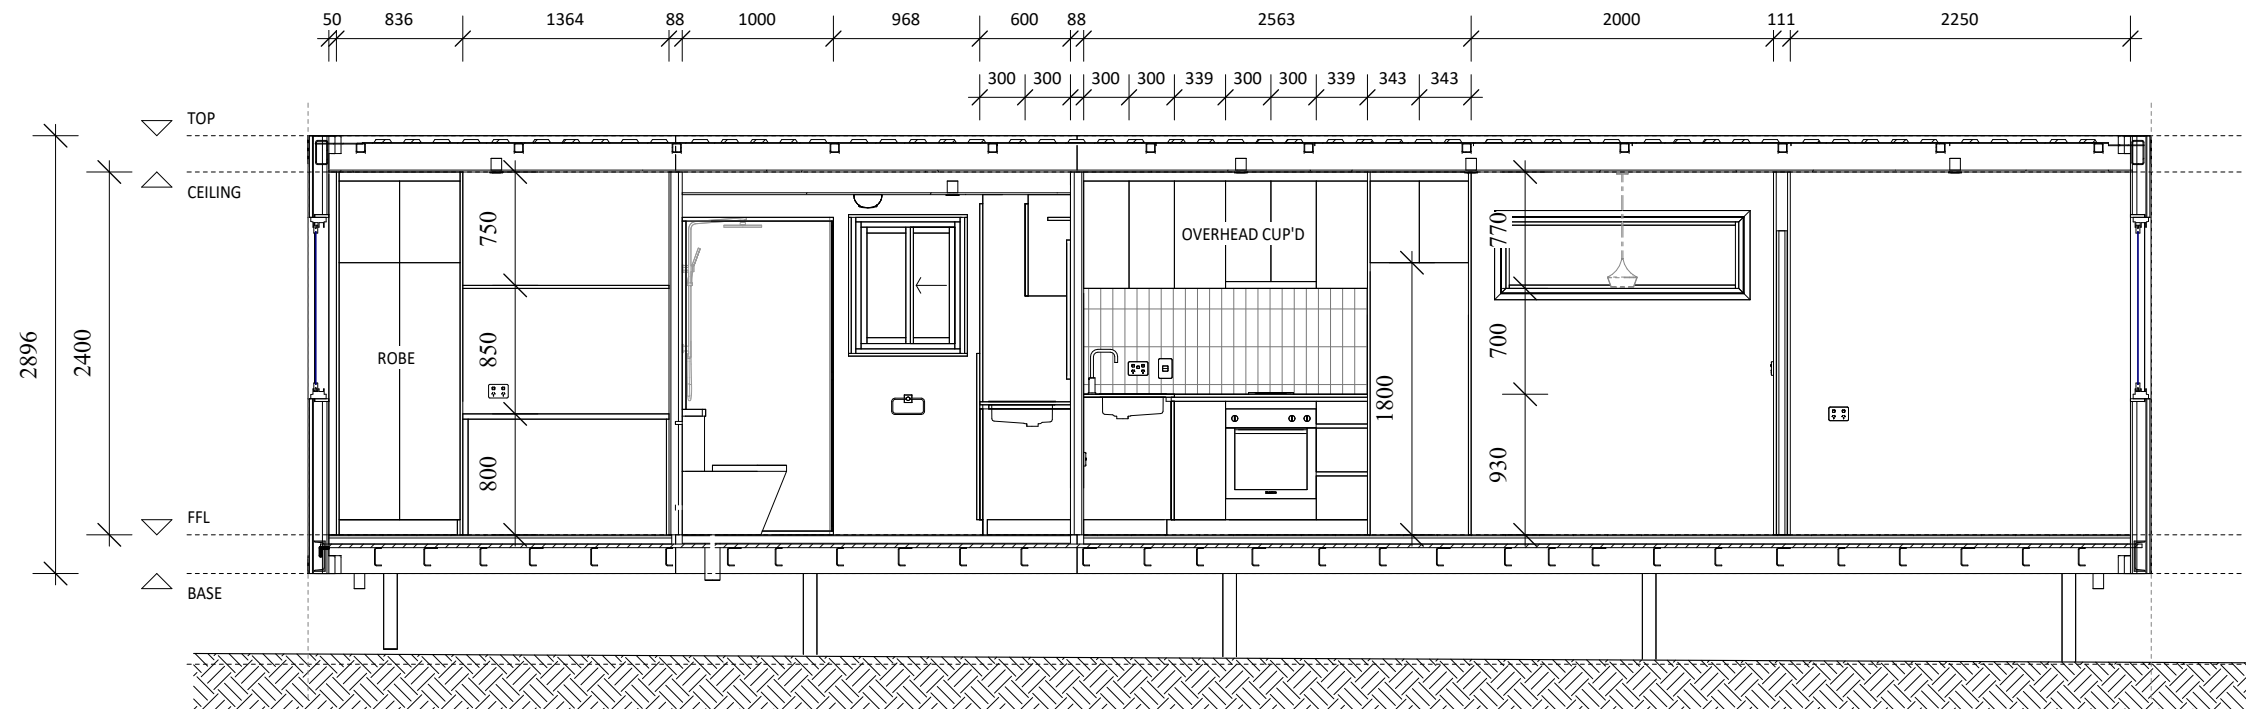

X1 Section 4
100 scale 1:50

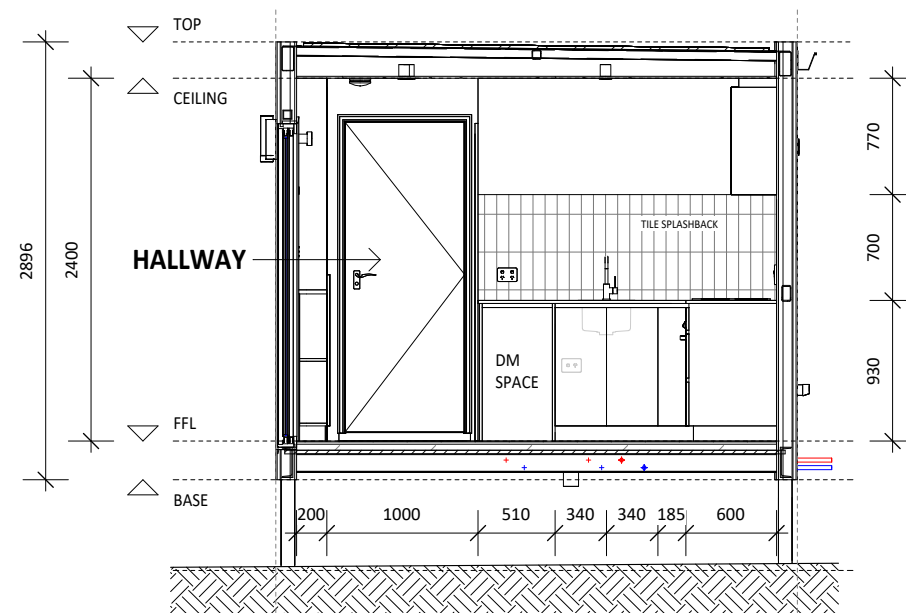


Y1 SECTION 3
100 scale 1:50

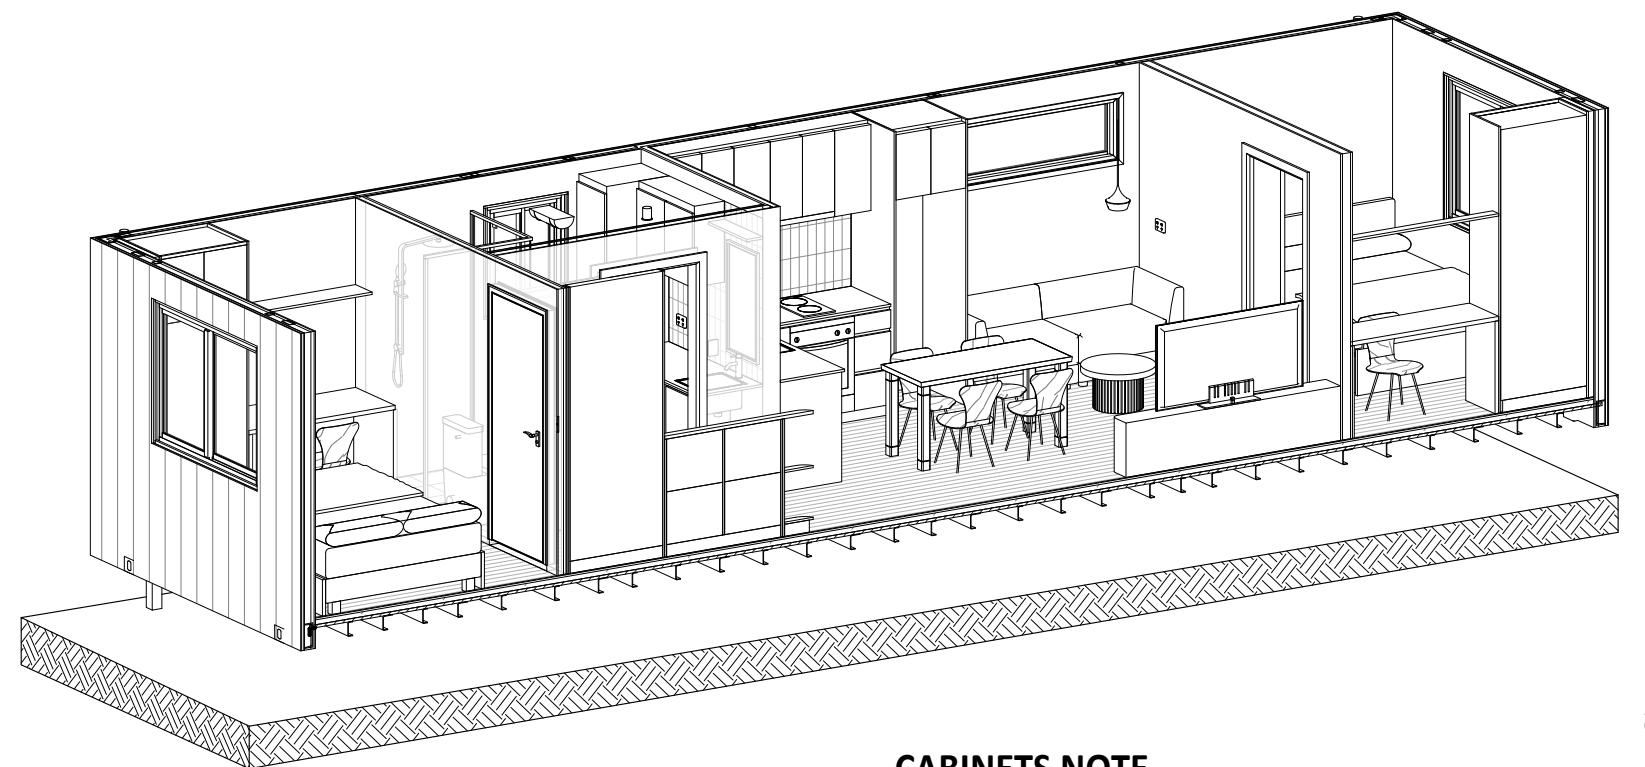


CABINETS NOTE

- ALL CABINETS SHOP DRAWINGS BY FACTORY TEAM. SITE MEASURE. REQUIRED, DIMENSIONS TO BE ADJUSTED ACCORDINGLY.
- MATERIALS AND FINISHES REFER TO COLOUR SCHEME AND MATERIAL SCHEDULE. TO BE CONFIRMED AT LATER DATE.
- FILLERS HAVE BEEN OMITTED FOR CLARITY. SIZES AND POSITIONS TO BE ROBE DECIDED BY THE FACTORY TEAM.
- ALL DRAWERS HAVE SOFT CLOSE TRACKS.
- DRAWER CARCASS COLOUR TO MATCH DOOR FRONT COLOUR, UNLESS BIN INSIDE CPB NOTED DIFFERENTLY.

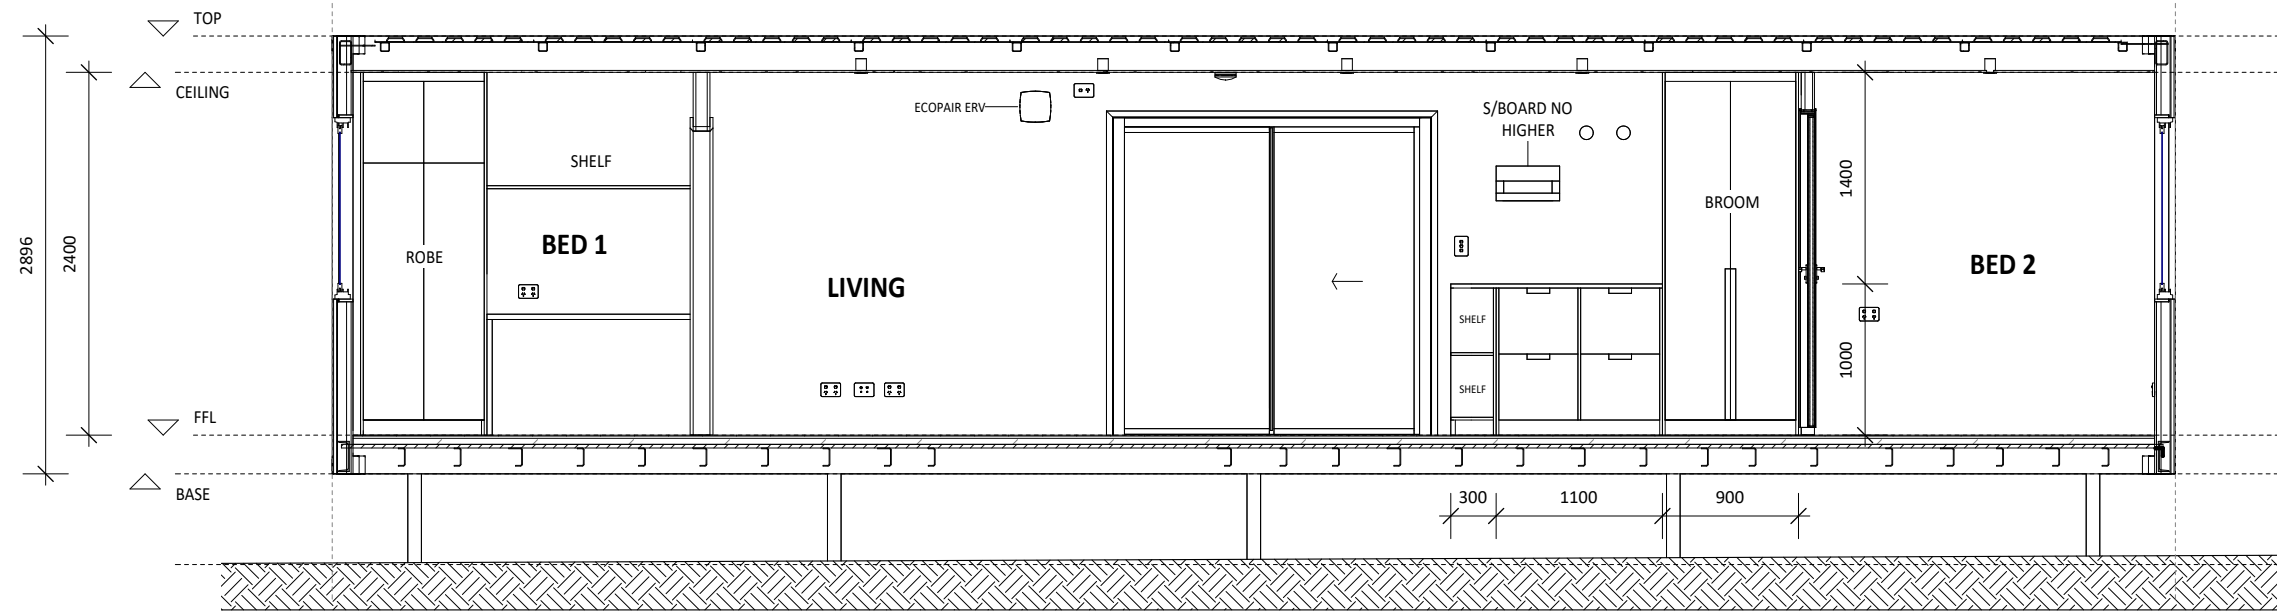

SECTION 1
X2
100 scale 1:50

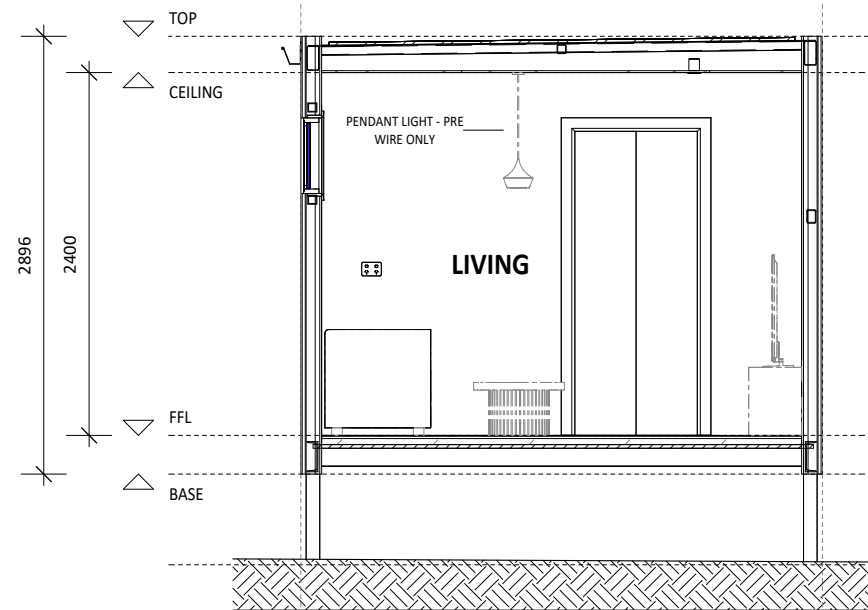


SECTION 2
Y2
100 scale 1:50




PRODUCTION SET

- ALL EXTERNAL ELEMENTS (PROPOSED DECK & ROOF) DESIGNED & SUPPLIED BY OTHERS.
- DOWNPIPES & GUTTER SUPPLIED INSTALLED ON SITE BY OTHERS.
- SUREFOOT STUMPS FOOTING LAYOUT REFERENCE ONLY, REFER ENGINEERING DRAWINGS.


WIND CLASSIFICATION - /
SOIL CLASSIFICATION - CLASS N/A

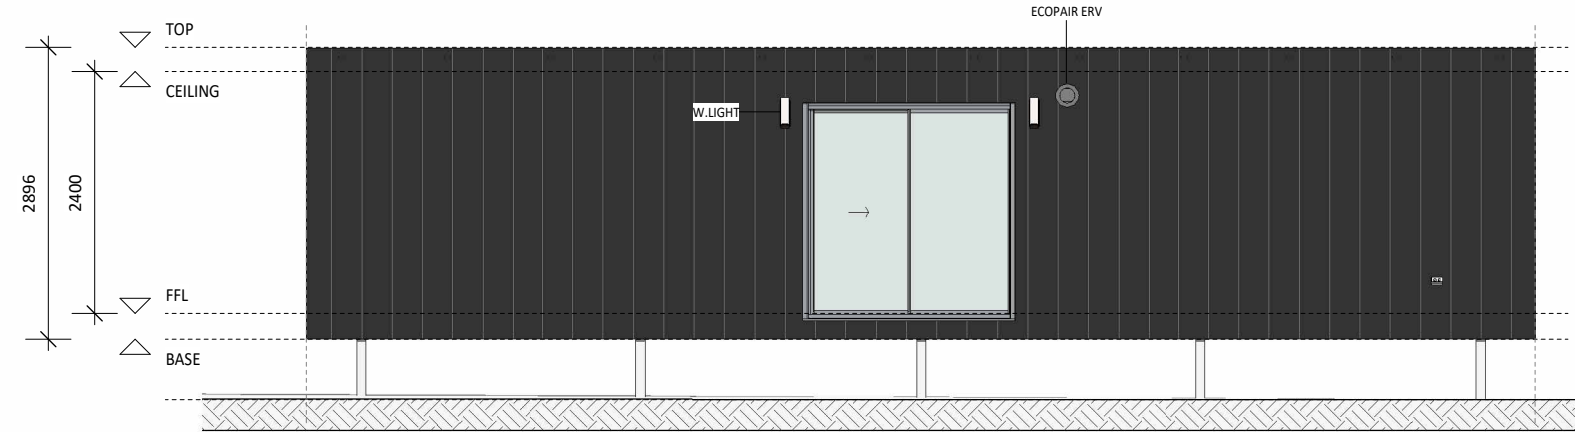


E1
100 scale 1:75
ELEVATION 1

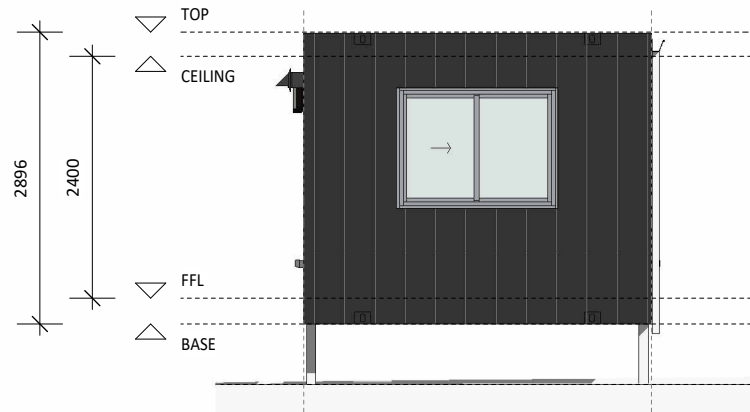

E2
100 scale 1:75
ELEVATION 2

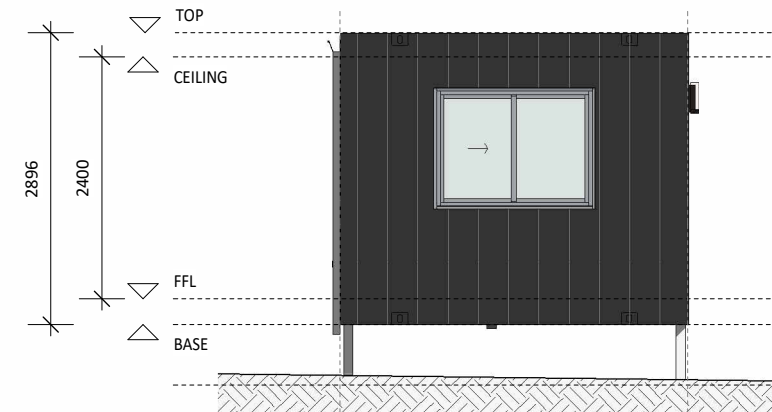

E4
100 scale 1:75
ELEVATION 4

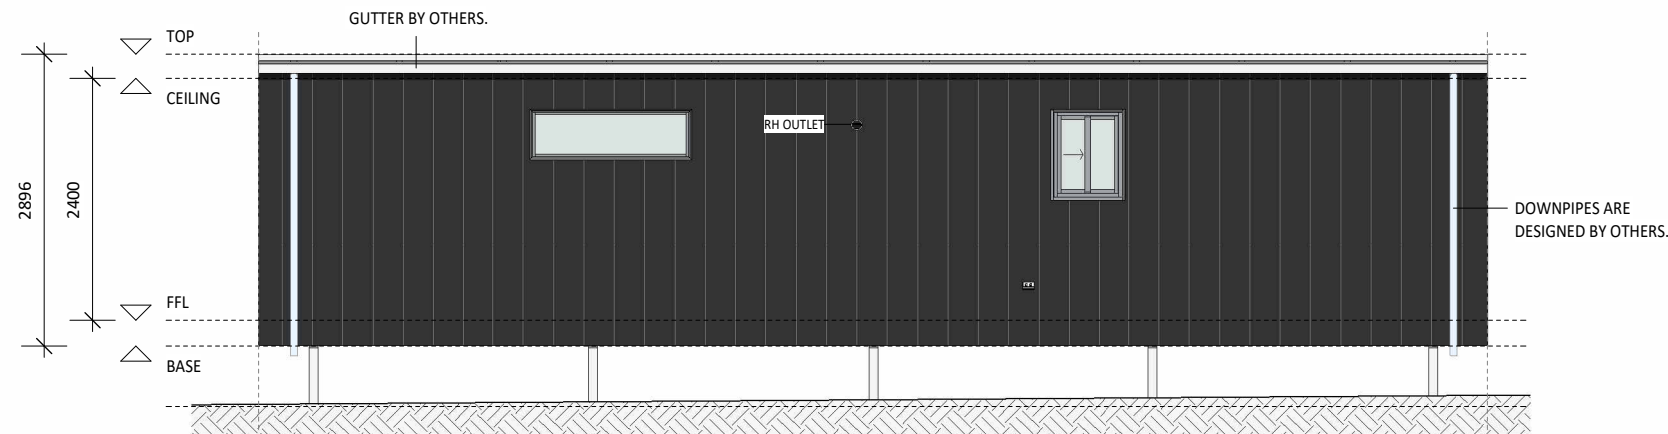

E3
100 scale 1:75
ELEVATION 3

REV	DESCRIPTION	DATE
A	Revision 1	22.07.2026

STYLE: **WILLOW**

ADDRESS:

CLIENT:

JOB NO.

SHEET **114**

SHEET TOTALS **19**